




ELEVATION @ HALL
SCALE: 1/4" = 1'-0"

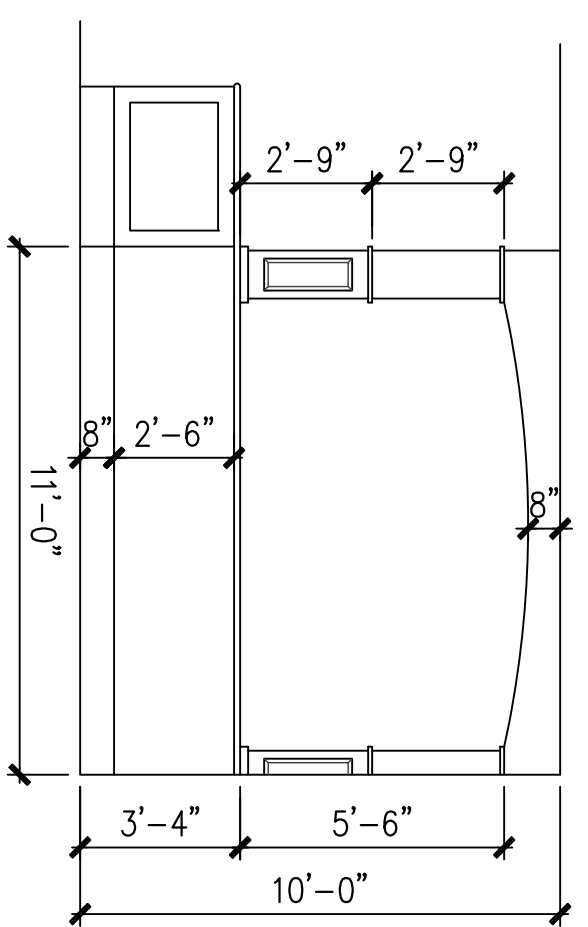


ELEVATION @ LIVING RM
SCALE: 1/4" = 1'-0"

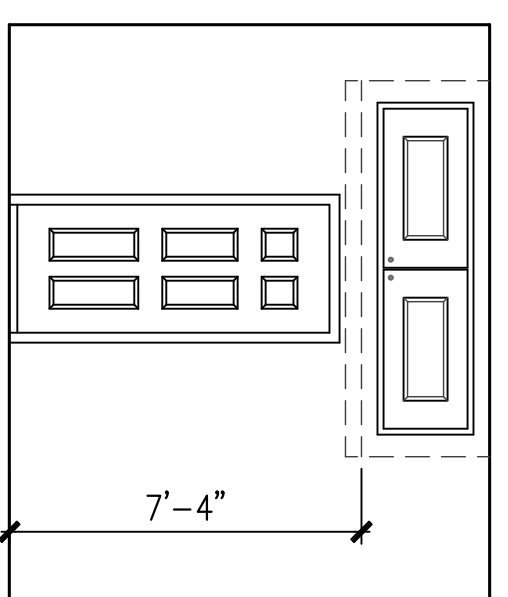


ELEVATION @ BEDROOM
SCALE: 1/4" = 1'-0"

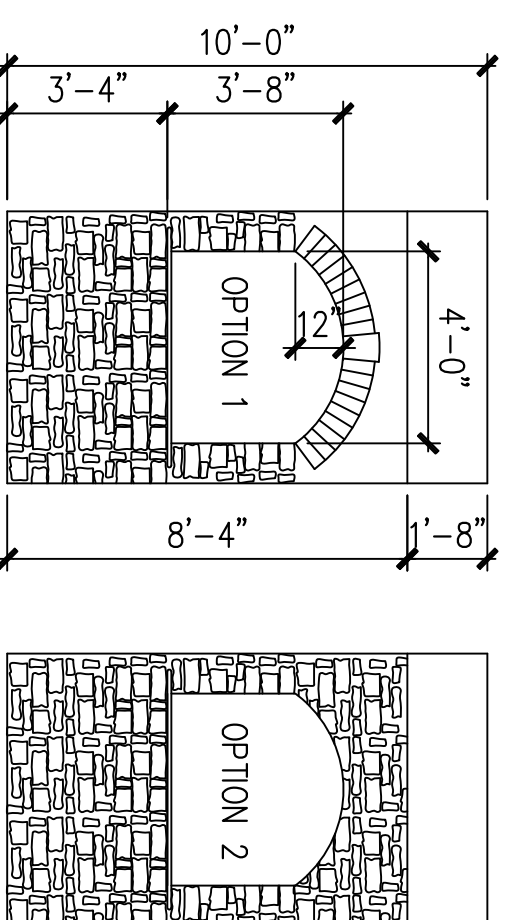


ELEVATION @ BUTLER PANTRY
SCALE: 1/4" = 1'-0"

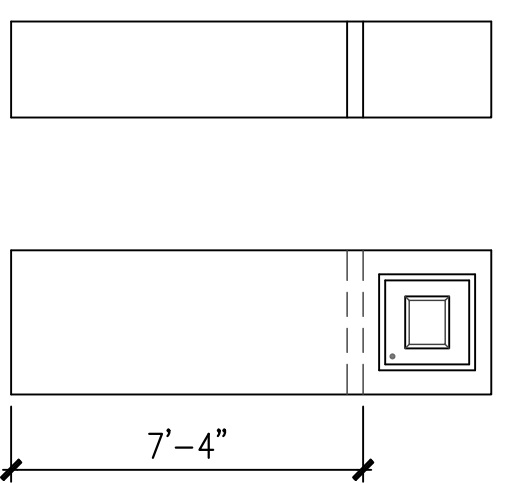


ELEVATION @ DEN CLOSET
SCALE: 1/4" = 1'-0"

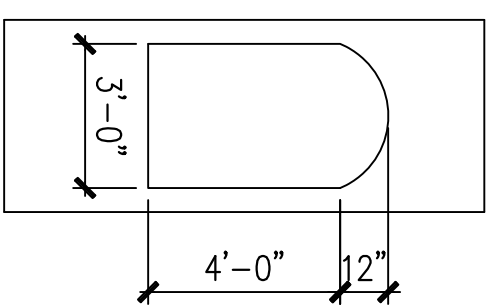


ELEVATION @ M. BED
SCALE: 1/4" = 1'-0"

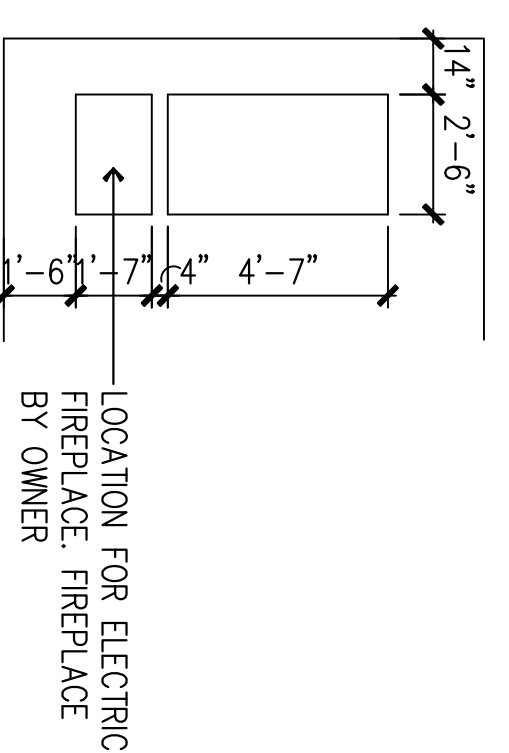


ELEVATION @ BEDROOM
SCALE: 1/4" = 1'-0"

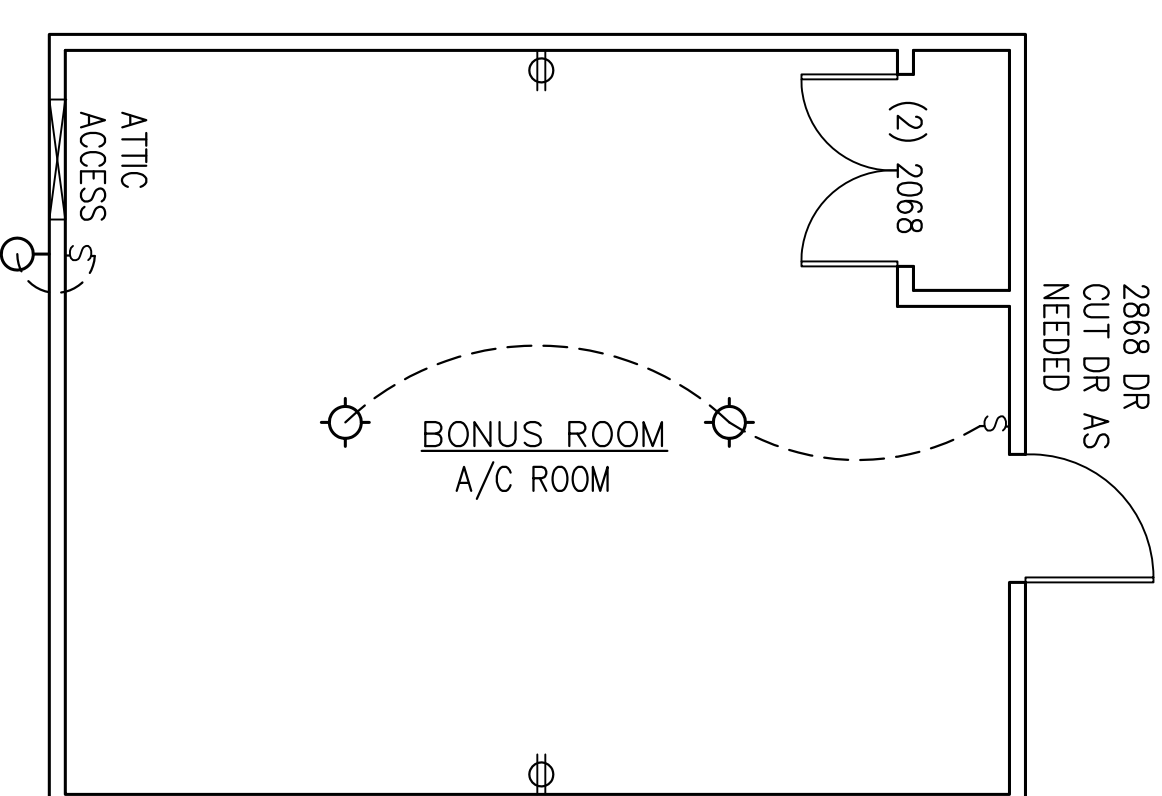

BONUS ROOM PLAN
SCALE: 1/4" = 1'-0"

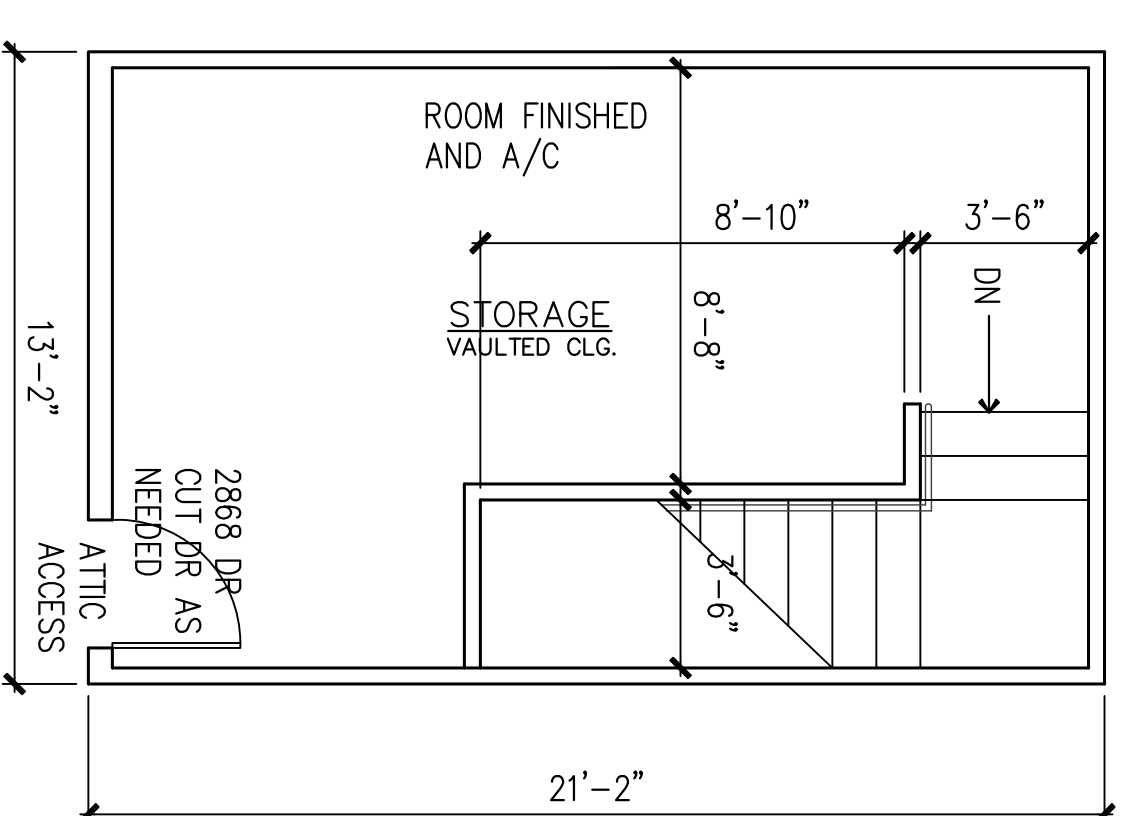

2nd STORAGE PLAN
SCALE: 1/4" = 1'-0"

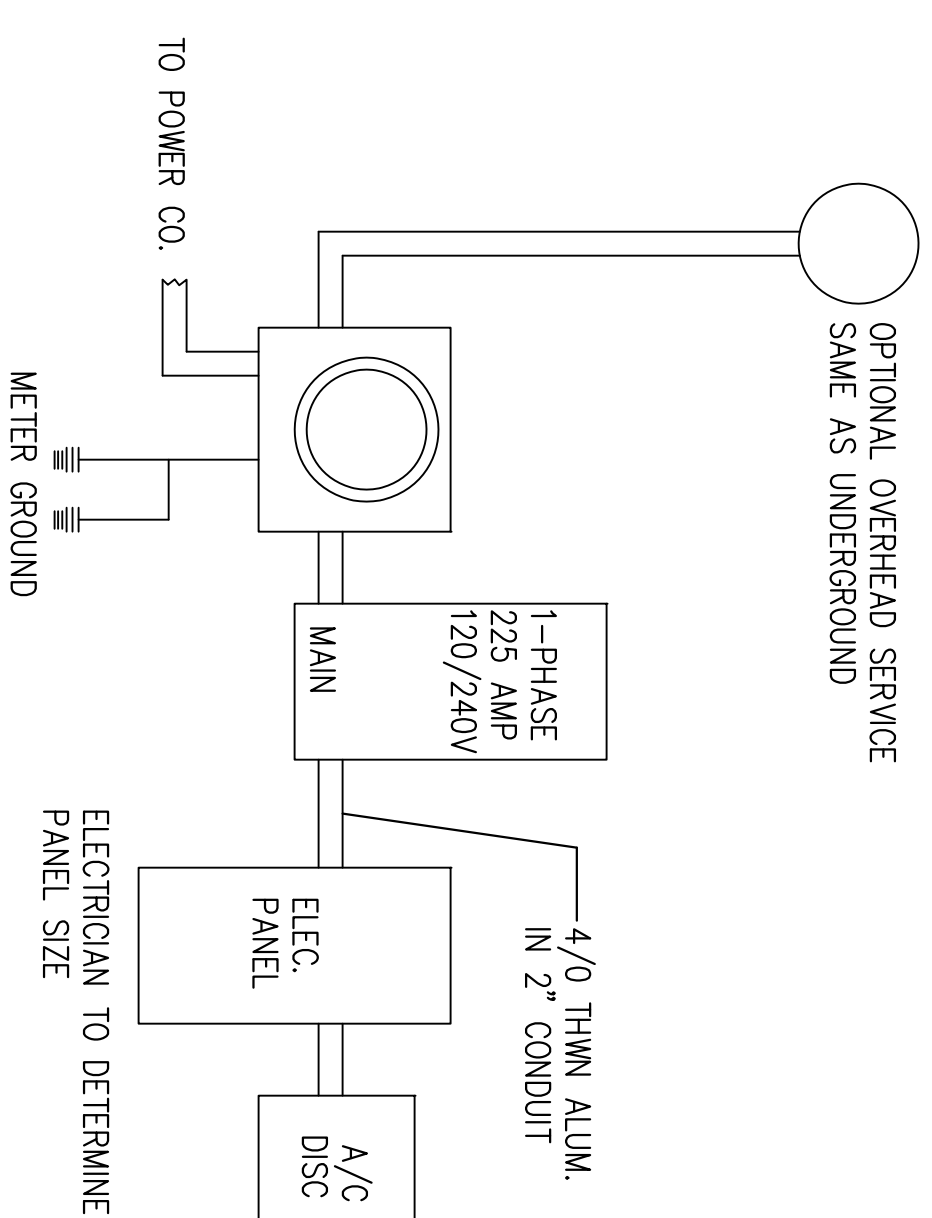

ELEC. RISER

ELECTRICAL LEGEND	
⊞	SWITCH
S ₃	THREE WAY SWITCH
S ₄	PULL CHAIN
⊞	PUSH BUTTON
⊞	110V DUPLEX OUTLET
⊞	SWITCHED DUPLEX OUTLET
⊞	220V OUTLET
⊞	FAN PRE-WIRE OUTLET
⊞	CEILING MOUNTED FIXTURE
⊞	WALL LIGHT FIXTURE
⊞	FLOOR LIGHT FIXTURE
⊞	RECESSED LIGHT
⊞	MN. RECESSED LIGHT
⊞	EXHAUST FAN
⊞	GARBAGE DISPOSAL
⊞	CABLE OUTLET PREWIRE
⊞	A/C THERMOSTAT
⊞	SPEAKER
⊞	PHONE OUTLET PREWIRE
⊞	FLOOD LIGHT
⊞	CARBON MONOXIDE ALARM
⊞	SMOKE DETECTOR
⊞	CARBON MONOXIDE DETECTOR
⊞	JUNCTION BOX
⊞	PANEL
⊞	ELEC. METER
⊞	DISCONNECT
⊞	DOOR CHIMES
⊞	GROUND FAULT INTERRUPTER
⊞	WEATHERPROOF OUTLET


NOTE: ALL BEDROOMS TO BE AFCI

FOR CONSTRUCTION 06/14/12

Rev.	No.	Date	Issue History

PLANS DRAWN BY:
B.C.'S DESIGN SERVICES
101 ALABAMA STATE BLVD, ABERDEEN, FLORIDA
32035
PHONE: 904-253-1233
WWW.BCSDESIGN.COM

BUILDING CONTRACTOR:
GOLDSMITH CONSTRUCTION

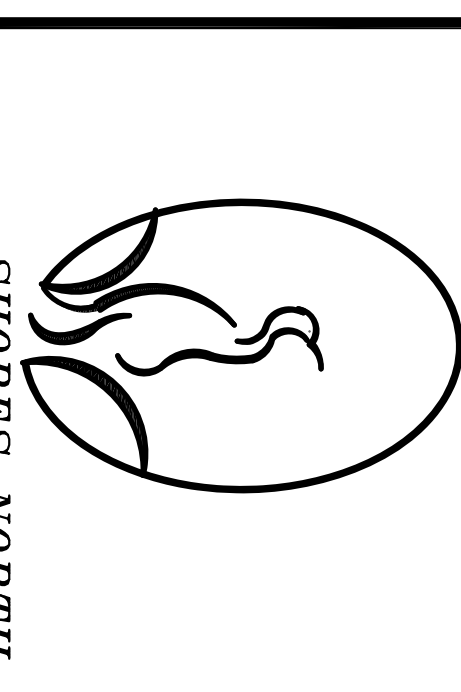

SHORES NORTH
ULTIMATE WIND SPEED 140 MPH CONVERSION FROM "C" TO "S"
= 140 / 1.40 = 100 MPH USE WIND SPEED 110 MPH WIND FORCE
FREQ 1609 EXPOSURE CATEGORY A
DESIGNER LOAD BEARING VALUE OF SOIL IS 1500 PSF ROOF
LIVE LOAD = 20 PSF FLOOR LIVE LOAD = 40 PSF RSK
WIND LOADS PER 2010 FB3 CHAPTER 16
ALL OTHER REQUIREMENTS TO MEET 2010 FB3 ALL
ALUMINUM IS 6063 - IS ALUMINUM ALLOY

STRUCTURAL ENGINEER
LEONARD G. WOOD P.E. #41317
4934 THE FENWAY MILLBERRY, FLORIDA 33960
(888) 430-2717 CELL

CONTRACTOR: GOLDSMITH CONSTRUCTION
SAMMET RESIDENCE
CONSTRUCTION ADDRESS: 459 MEANDERING WAY

CUSTOM HOME FOR
SAMMET RESIDENCE
PHASE 4
LOT 64

DATE	06/14/12
BY	B.C.C.
BY	L.W.

INTERIOR DETAILS
AND PLANS
A.3